


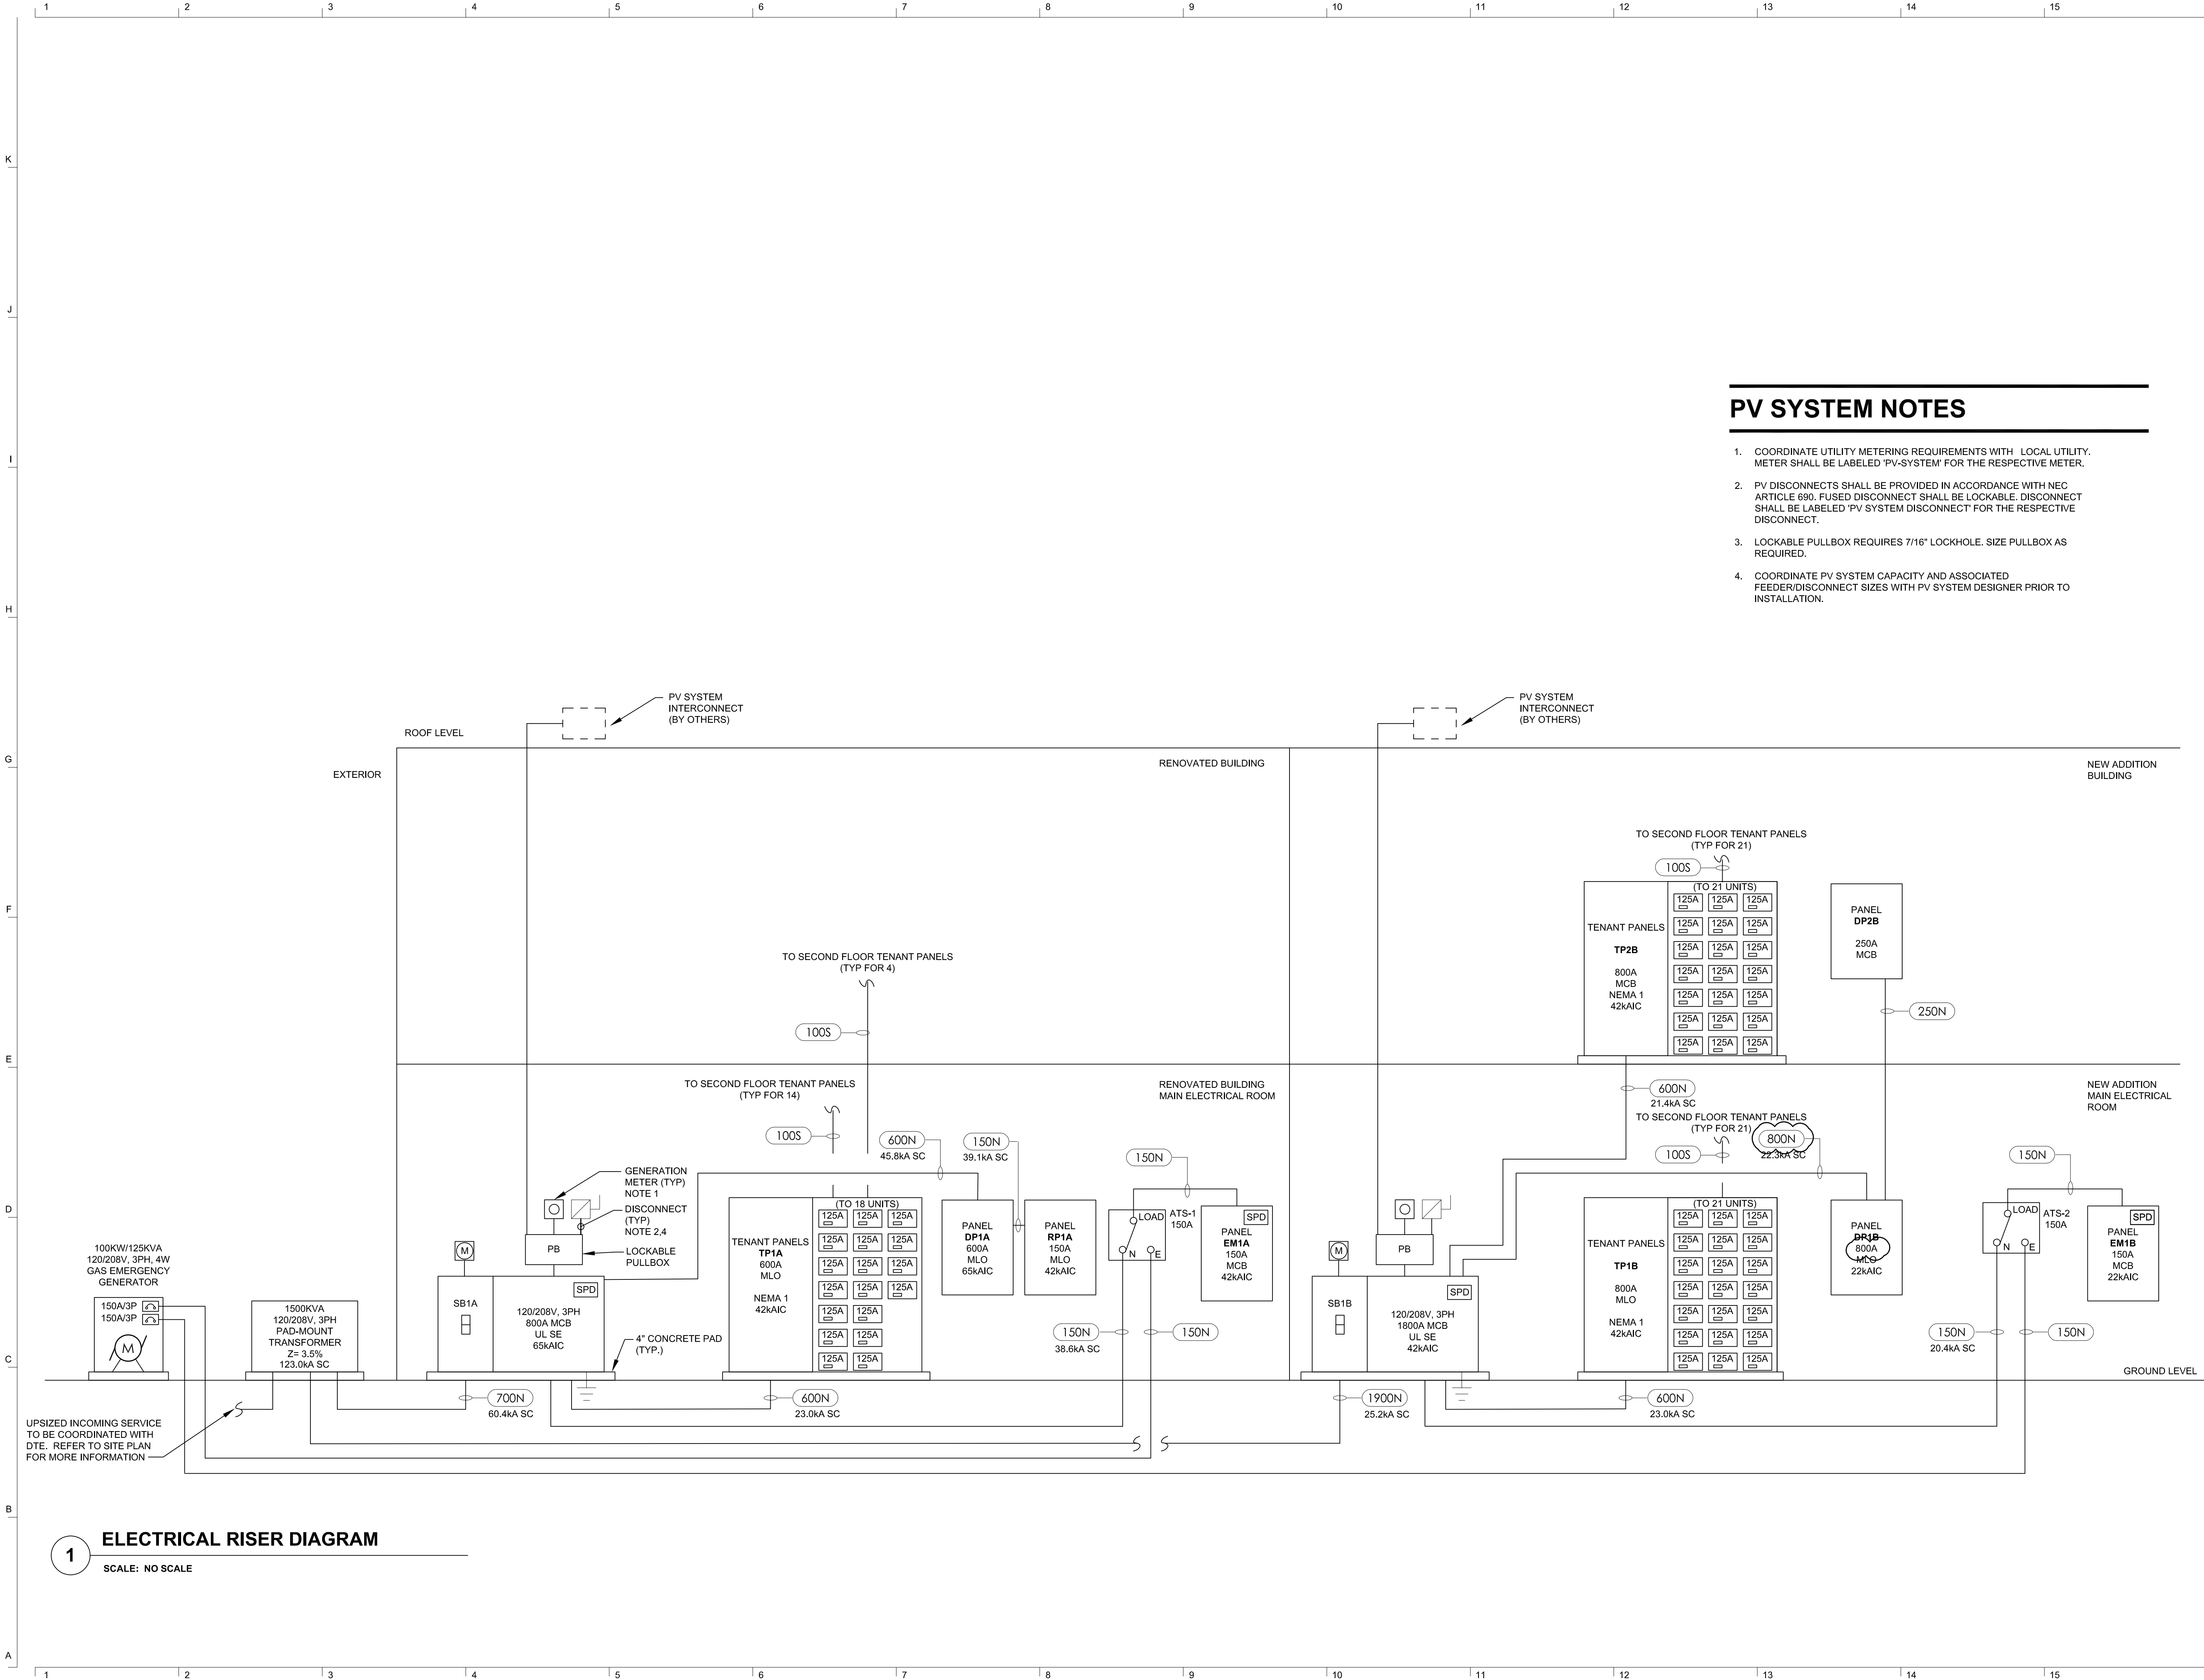


1 ELECTRICAL RISER DIAGRAM
SCALE: NO SCALE

PV SYSTEM NOTES

- COORDINATE UTILITY METERING REQUIREMENTS WITH LOCAL UTILITY. METER SHALL BE LABELED 'PV-SYSTEM' FOR THE RESPECTIVE METER.
- PV DISCONNECTS SHALL BE PROVIDED IN ACCORDANCE WITH NEC ARTICLE 690. FUSED DISCONNECT SHALL BE LOCKABLE. DISCONNECT SHALL BE LABELED 'PV SYSTEM DISCONNECT' FOR THE RESPECTIVE DISCONNECT.
- LOCKABLE PULLBOX REQUIRES 7/16" LOCKHOLE. SIZE PULLBOX AS REQUIRED.
- COORDINATE PV SYSTEM CAPACITY AND ASSOCIATED FEEDER/DISCONNECT SIZES WITH PV SYSTEM DESIGNER PRIOR TO INSTALLATION.

John Grace Arms
21030 Indian St, Southfield MI 48033
Developed by
John Grace Arms LDHA LLC

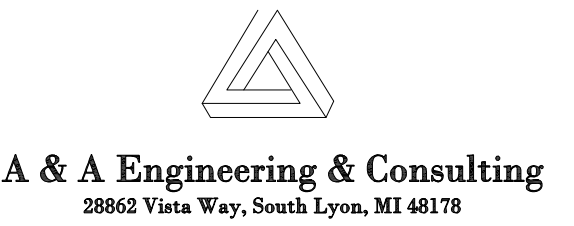

KEY PLANS

SHEET TITLE
**ELECTRICAL RISER
DIAGRAM - EXISTING &
NEW ADDITION**

SCALE: AS NOTED

ISSUED FOR	DATE
Permits	12.20.202
Bulletin No. 3	05.19.202

DRAWN BY	
CHECKED	
APPROVED	
21026.00	
FILE NO.	E-004
SHEET NO.	