


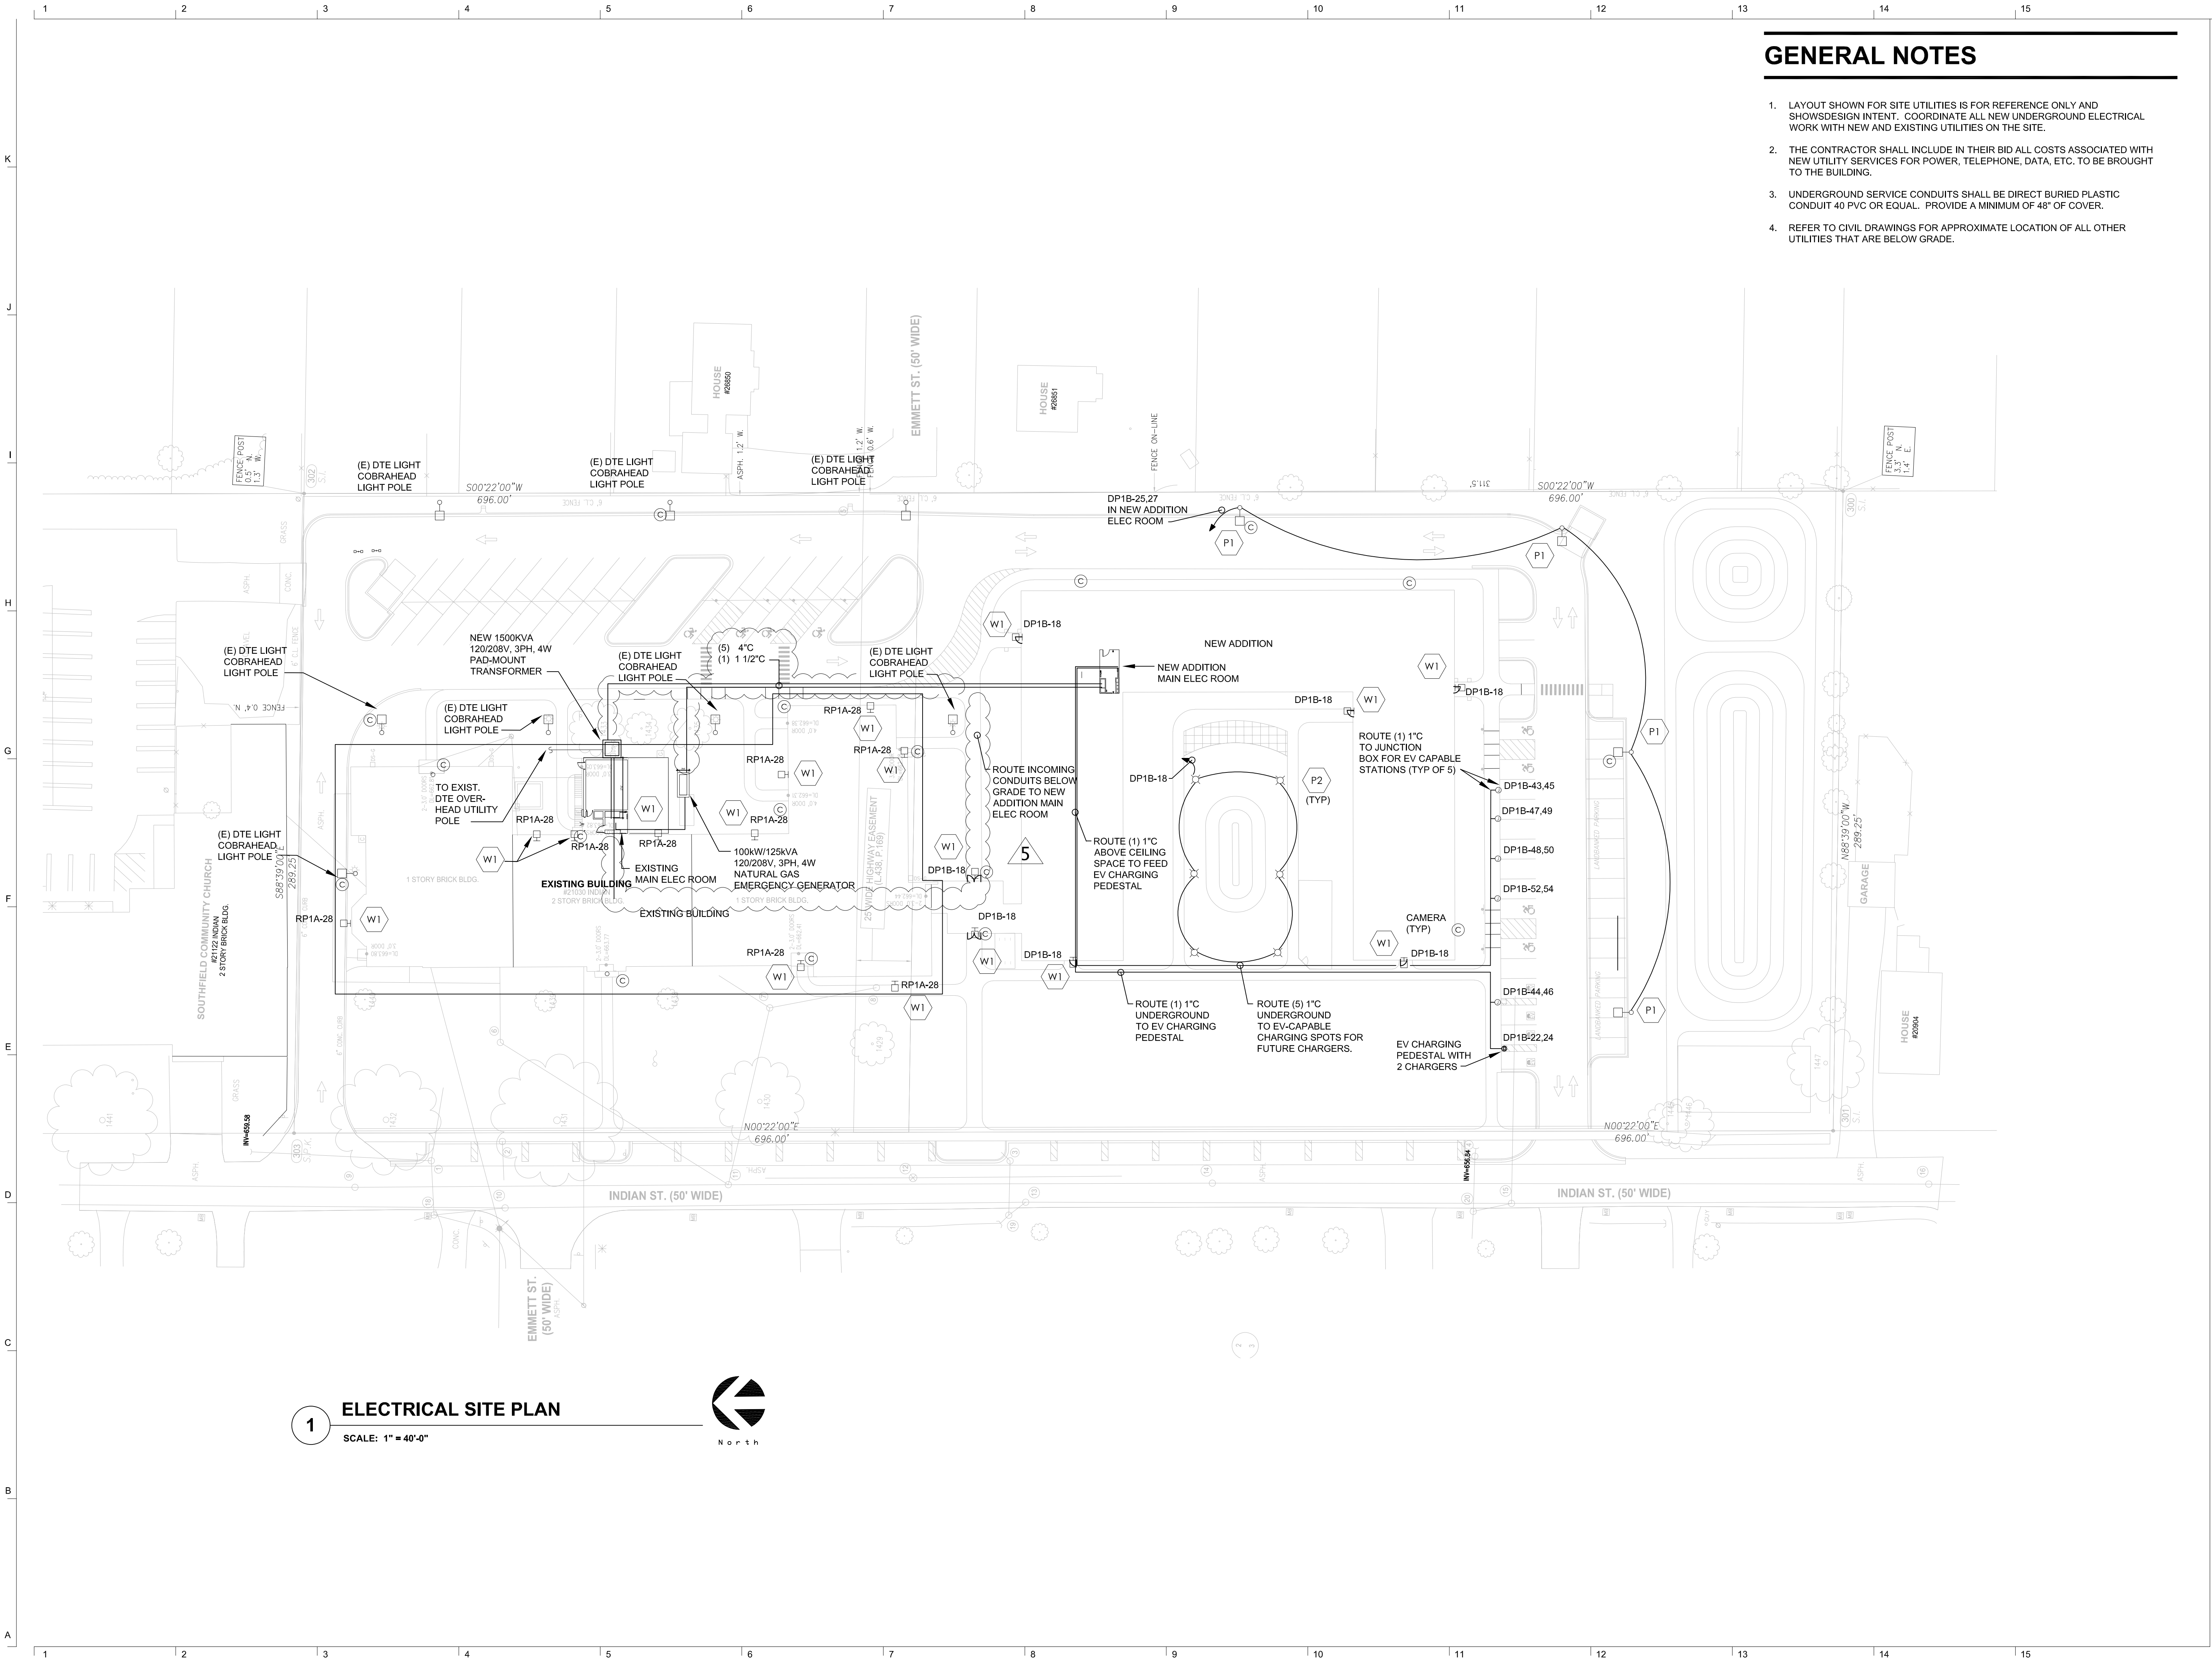

GENERAL NOTES

- 1. LAYOUT SHOWN FOR SITE UTILITIES IS FOR REFERENCE ONLY AND SHOWS DESIGN INTENT. COORDINATE ALL NEW UNDERGROUND ELECTRICAL WORK WITH NEW AND EXISTING UTILITIES ON THE SITE.
- 2. THE CONTRACTOR SHALL INCLUDE IN THEIR BID ALL COSTS ASSOCIATED WITH NEW UTILITY SERVICES FOR POWER, TELEPHONE, DATA, ETC. TO BE BROUGHT TO THE BUILDING.
- 3. UNDERGROUND SERVICE CONDUITS SHALL BE DIRECT BURIED PLASTIC CONDUIT 40 PVC OR EQUAL. PROVIDE A MINIMUM OF 48" OF COVER.
- 4. REFER TO CIVIL DRAWINGS FOR APPROXIMATE LOCATION OF ALL OTHER UTILITIES THAT ARE BELOW GRADE.

John Grace Arms
21030 Indian St, Southfield MI 48033
Developed by
John Grace Arms LDHA LLC

SDG
Architects + Planners
607 Shelby Street
Suite 704
Detroit, MI 48226
Tel: 313-961-9000
Fax: 313-964-3233

A & A Engineering & Consulting
28862 Vista Way, South Lyon, MI 48178

REGISTRATION SEAL

KEY PLANS

SHEET TITLE
ELECTRICAL SITE PLAN

SCALE: AS NOTED

ISSUED FOR	DATE
Permits	12.20.2024
Bulletin No. 1	02.19.2025
Bulletin No. 2	03.05.2025
Bulletin No. 5	10.13.2025

DRAWN BY SC

CHECKED MJ

APPROVED

21026.00

FILE NO.

ES-101

SHEET NO.