



REGISTRATION SEAL



## KEY PLANS

SHEET TITLE

FIRST FLOOR  
MECHANICAL HVAC  
PLAN

SCALE: AS NOTED

| ISSUED FOR          | DATE     |
|---------------------|----------|
| PERMIT              | 10.20.24 |
| <u>Δ BULLETIN 2</u> | 3.05.25  |
| <u>Δ BULLETIN 3</u> | 5.19.25  |
| <u>Δ BULLETIN 6</u> | 12.03.25 |

DRAWN BY

CHECKED


APPROVED

21026.00

FILE NO.

# M-101

SHEET NO.

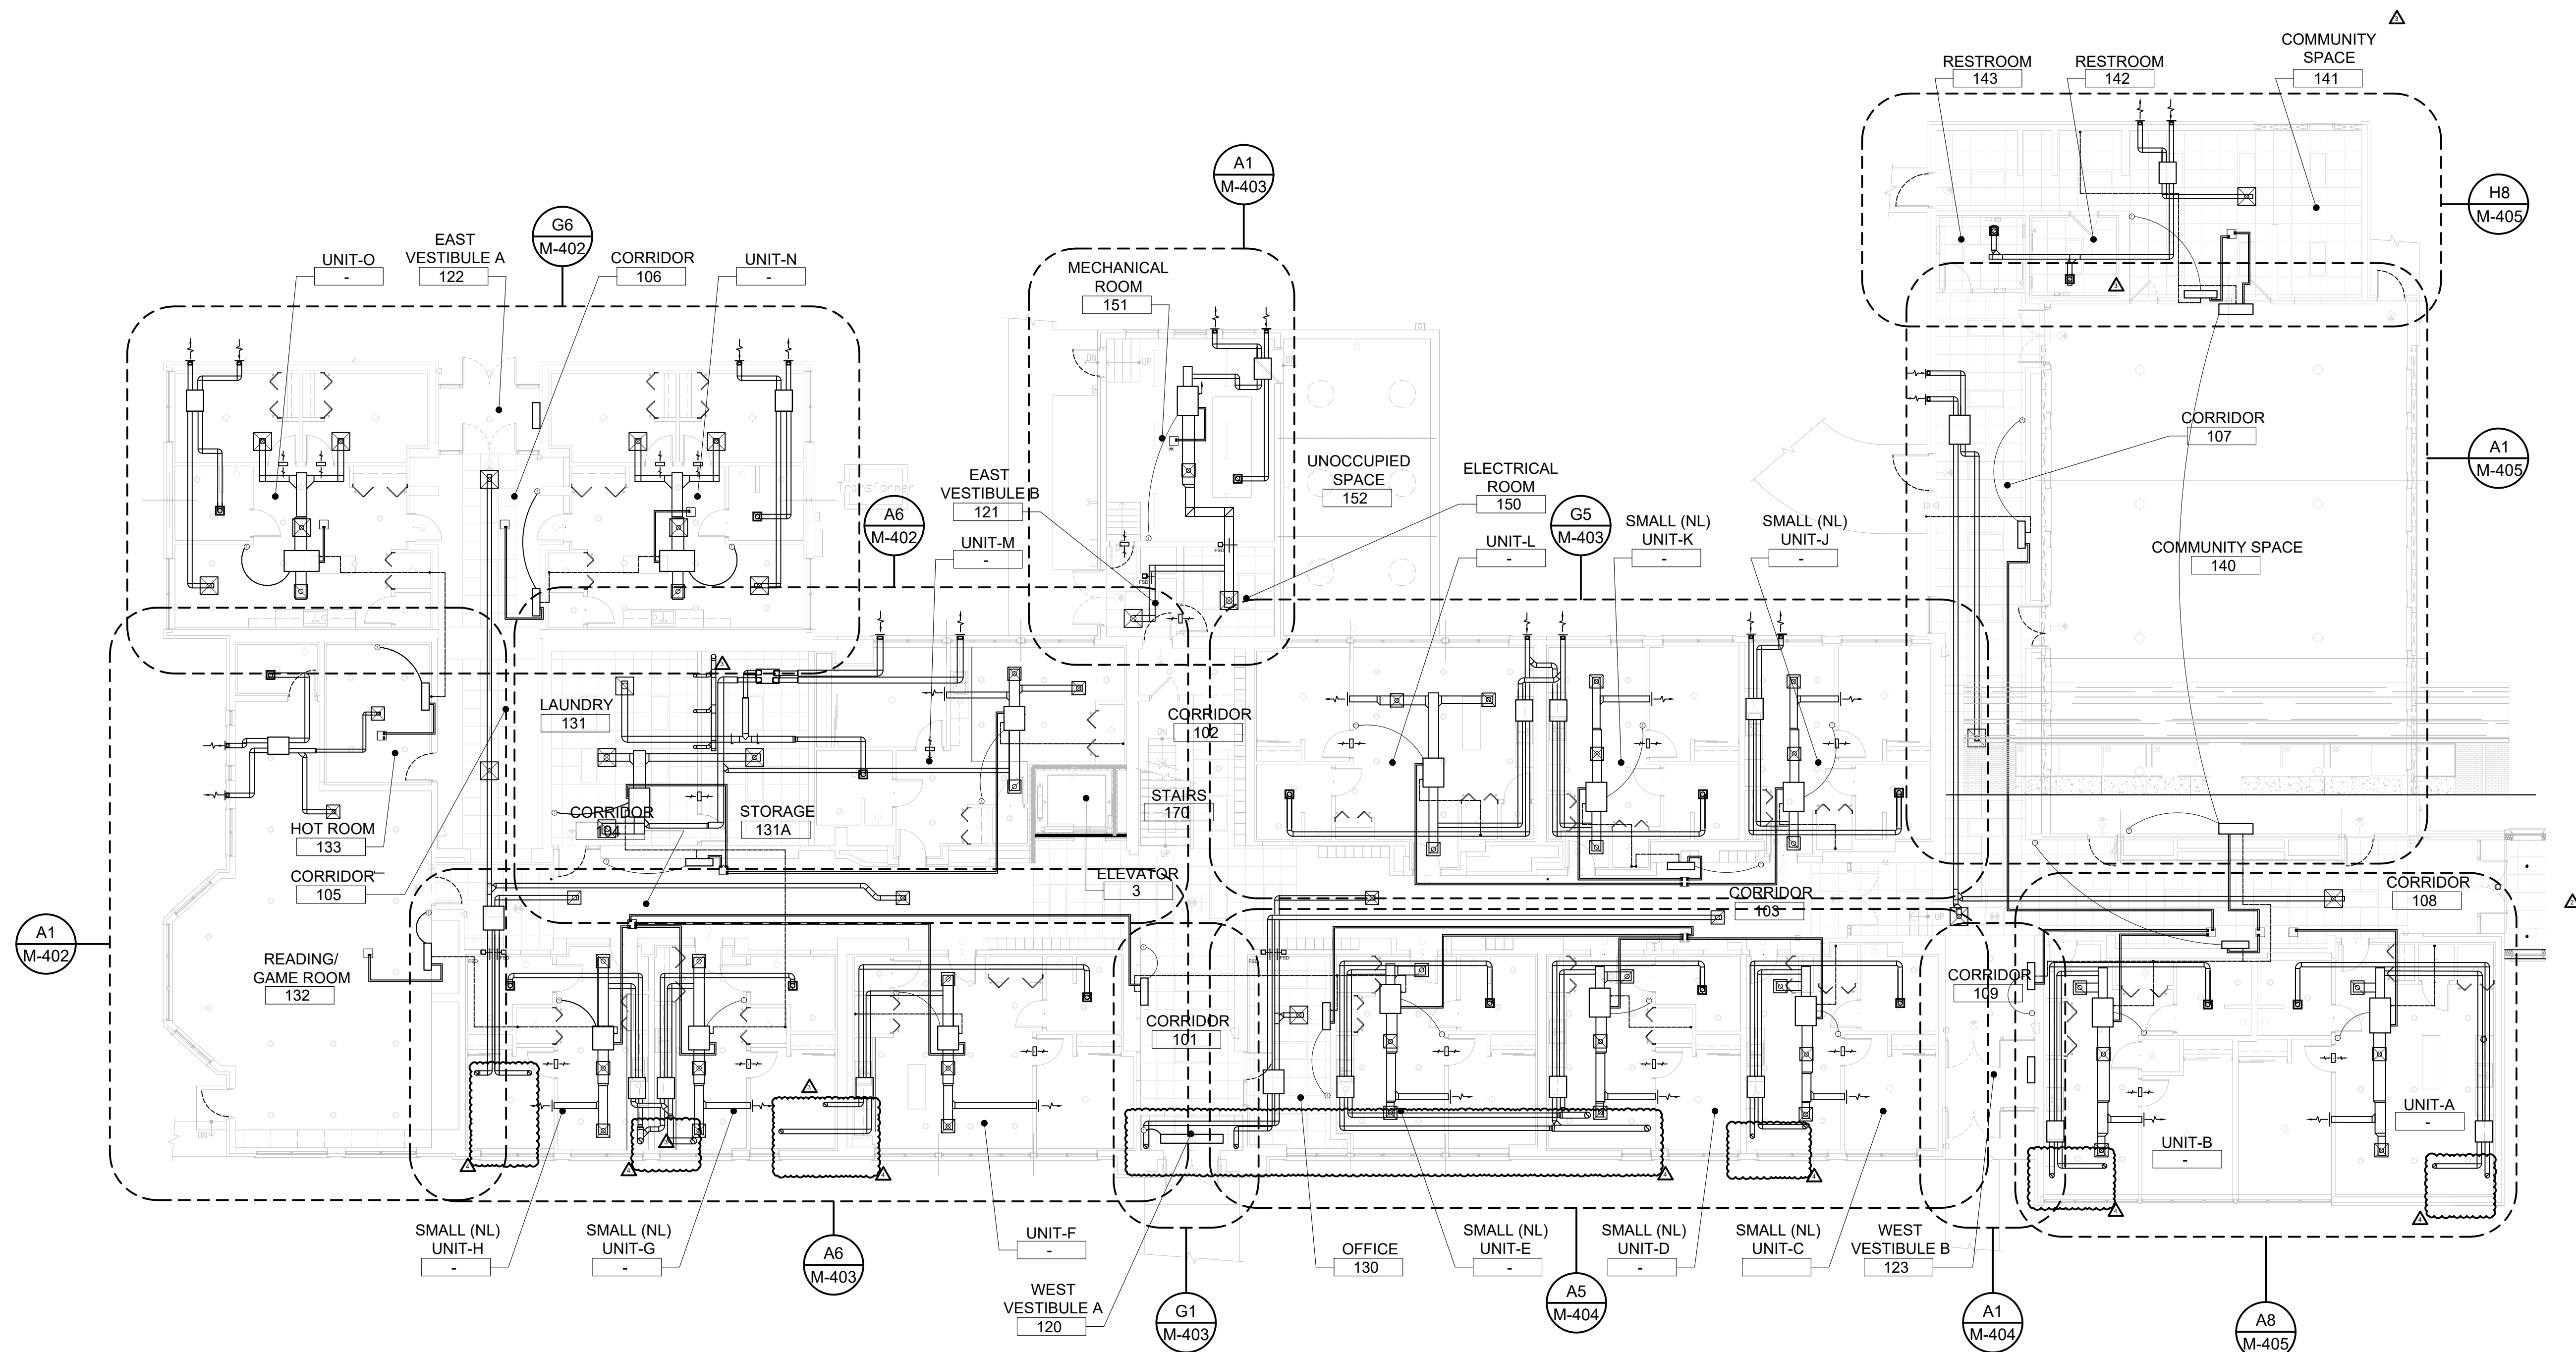

## A1

## FIRST FLOOR MECHANICAL HVAC PLAN

M-101

SCALE: 3/32" = 1'-0"