



307 Shelby Street
Suite 704
Detroit, MI 48226

Tel: 313-961-9000
Fax: 313-964-3233



A & A Engineering & Consulting
28862 Vista Way, South Lyon, MI 48178

REGISTRATION SEAL



KEY PLANS

EET TITLE

SECOND FLOOR - MECHANICAL HVAC PLAN

CALE: AS NOTED

ISSUED FOR	DATE
PERMIT	10.20.24
Δ BULLETIN 3	5.19.25
Δ BULLETIN 6	12.03.25

DRAWN BY

CHECKED


PROVED

21026.00

E NO.

M-103

EET NO.

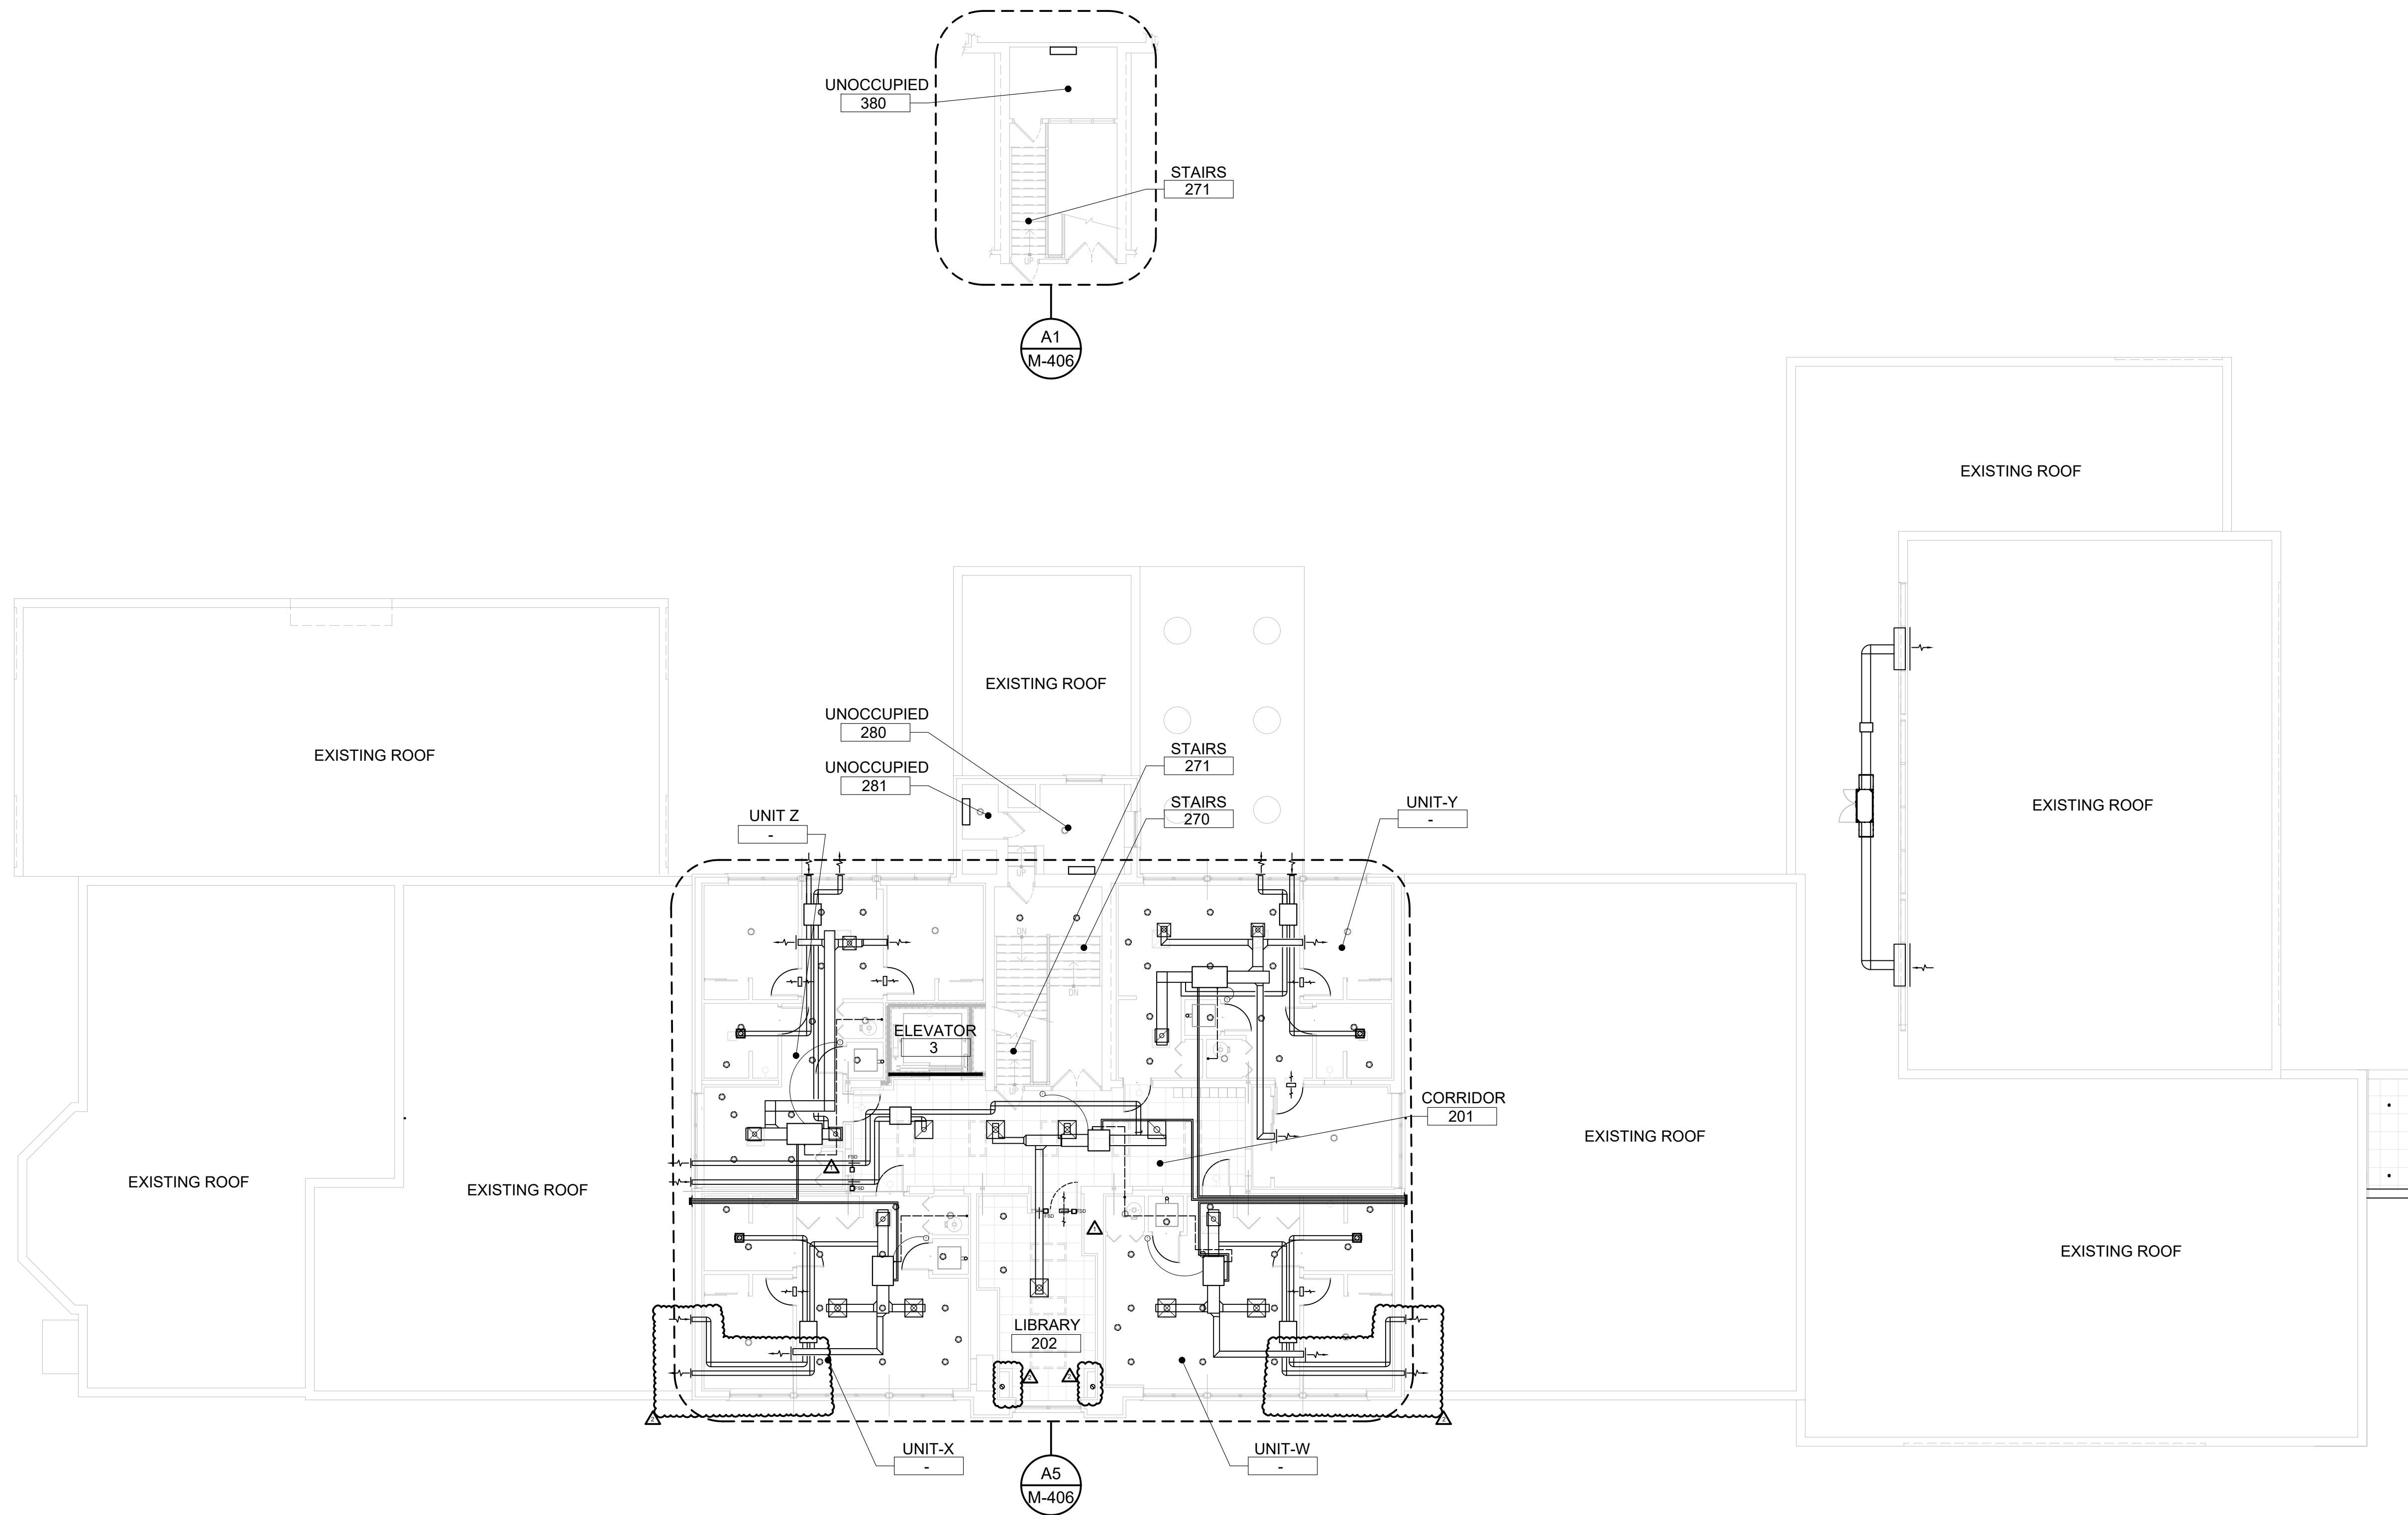

1. SEE SHEET NOTES AND SHEET KEYED NOTES ON M-001

A1

SECOND FLOOR - MECHANICAL HVAC PLAN

M-103

M-103

SCALE: 3/32" = 1'-0"